


85 main street
hopkinton, massachusetts

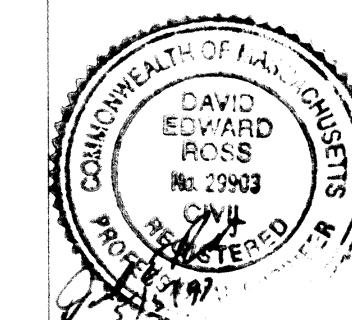

Civil Engineer, Landscape Architect,
Land Surveyor & Environmental Consultant
DAVID E. ROSS ASSOCIATES, INC.
111 Fitchburg Road
P.O. Box 368
Ayer, MA 01432
(508) 772-6232 FAX (508) 772-6258

LEGEND

- EXISTING PROPERTY LINE
- EDGE OF PAVEMENT
- EXISTING CONTOUR
- PROPOSED CONTOUR
- EXISTING TREELINE / BRUSHLINE
- GUY POLE
- OVERHEAD WIRES
- UTILITY POLE
- LIGHT SIGN
- EXISTING CATCHBASIN
- PROPOSED CATCHBASIN
- DRAIN MANHOLE
- DRAIN LINE
- HYDRANT
- WATER GATE
- WATER LINE
- SEWER MANHOLE
- SEWER LINE
- GAS GATE
- GAS LINE
- PERC TEST
- DEEP HOLE TEST
- UNDERGROUND UTILITIES
- SILT FENCE/HAYBALE BARRIER
- INTERCEPTOR DRAIN LINE
- FIRE CISTERN PIPE LINE
- PROP. SPOT GRADE

REVISIONS

5/5/97 GENERAL REVISION

THIS PLAN IS PART OF A SET OF PLANS AND SPECIFICATIONS, AND IS NOT TO BE USED AS A SOLE SOURCE OF INFORMATION.

SEEKONK PUBLIC SAFETY FACILITY

SEEKONK, MASSACHUSETTS

GRADING & DRAINAGE PLAN

scale 1" = 20'


date JANUARY 1997

drawn by MLC

job no DER 8739 602

sheet 3 of 6

C-3

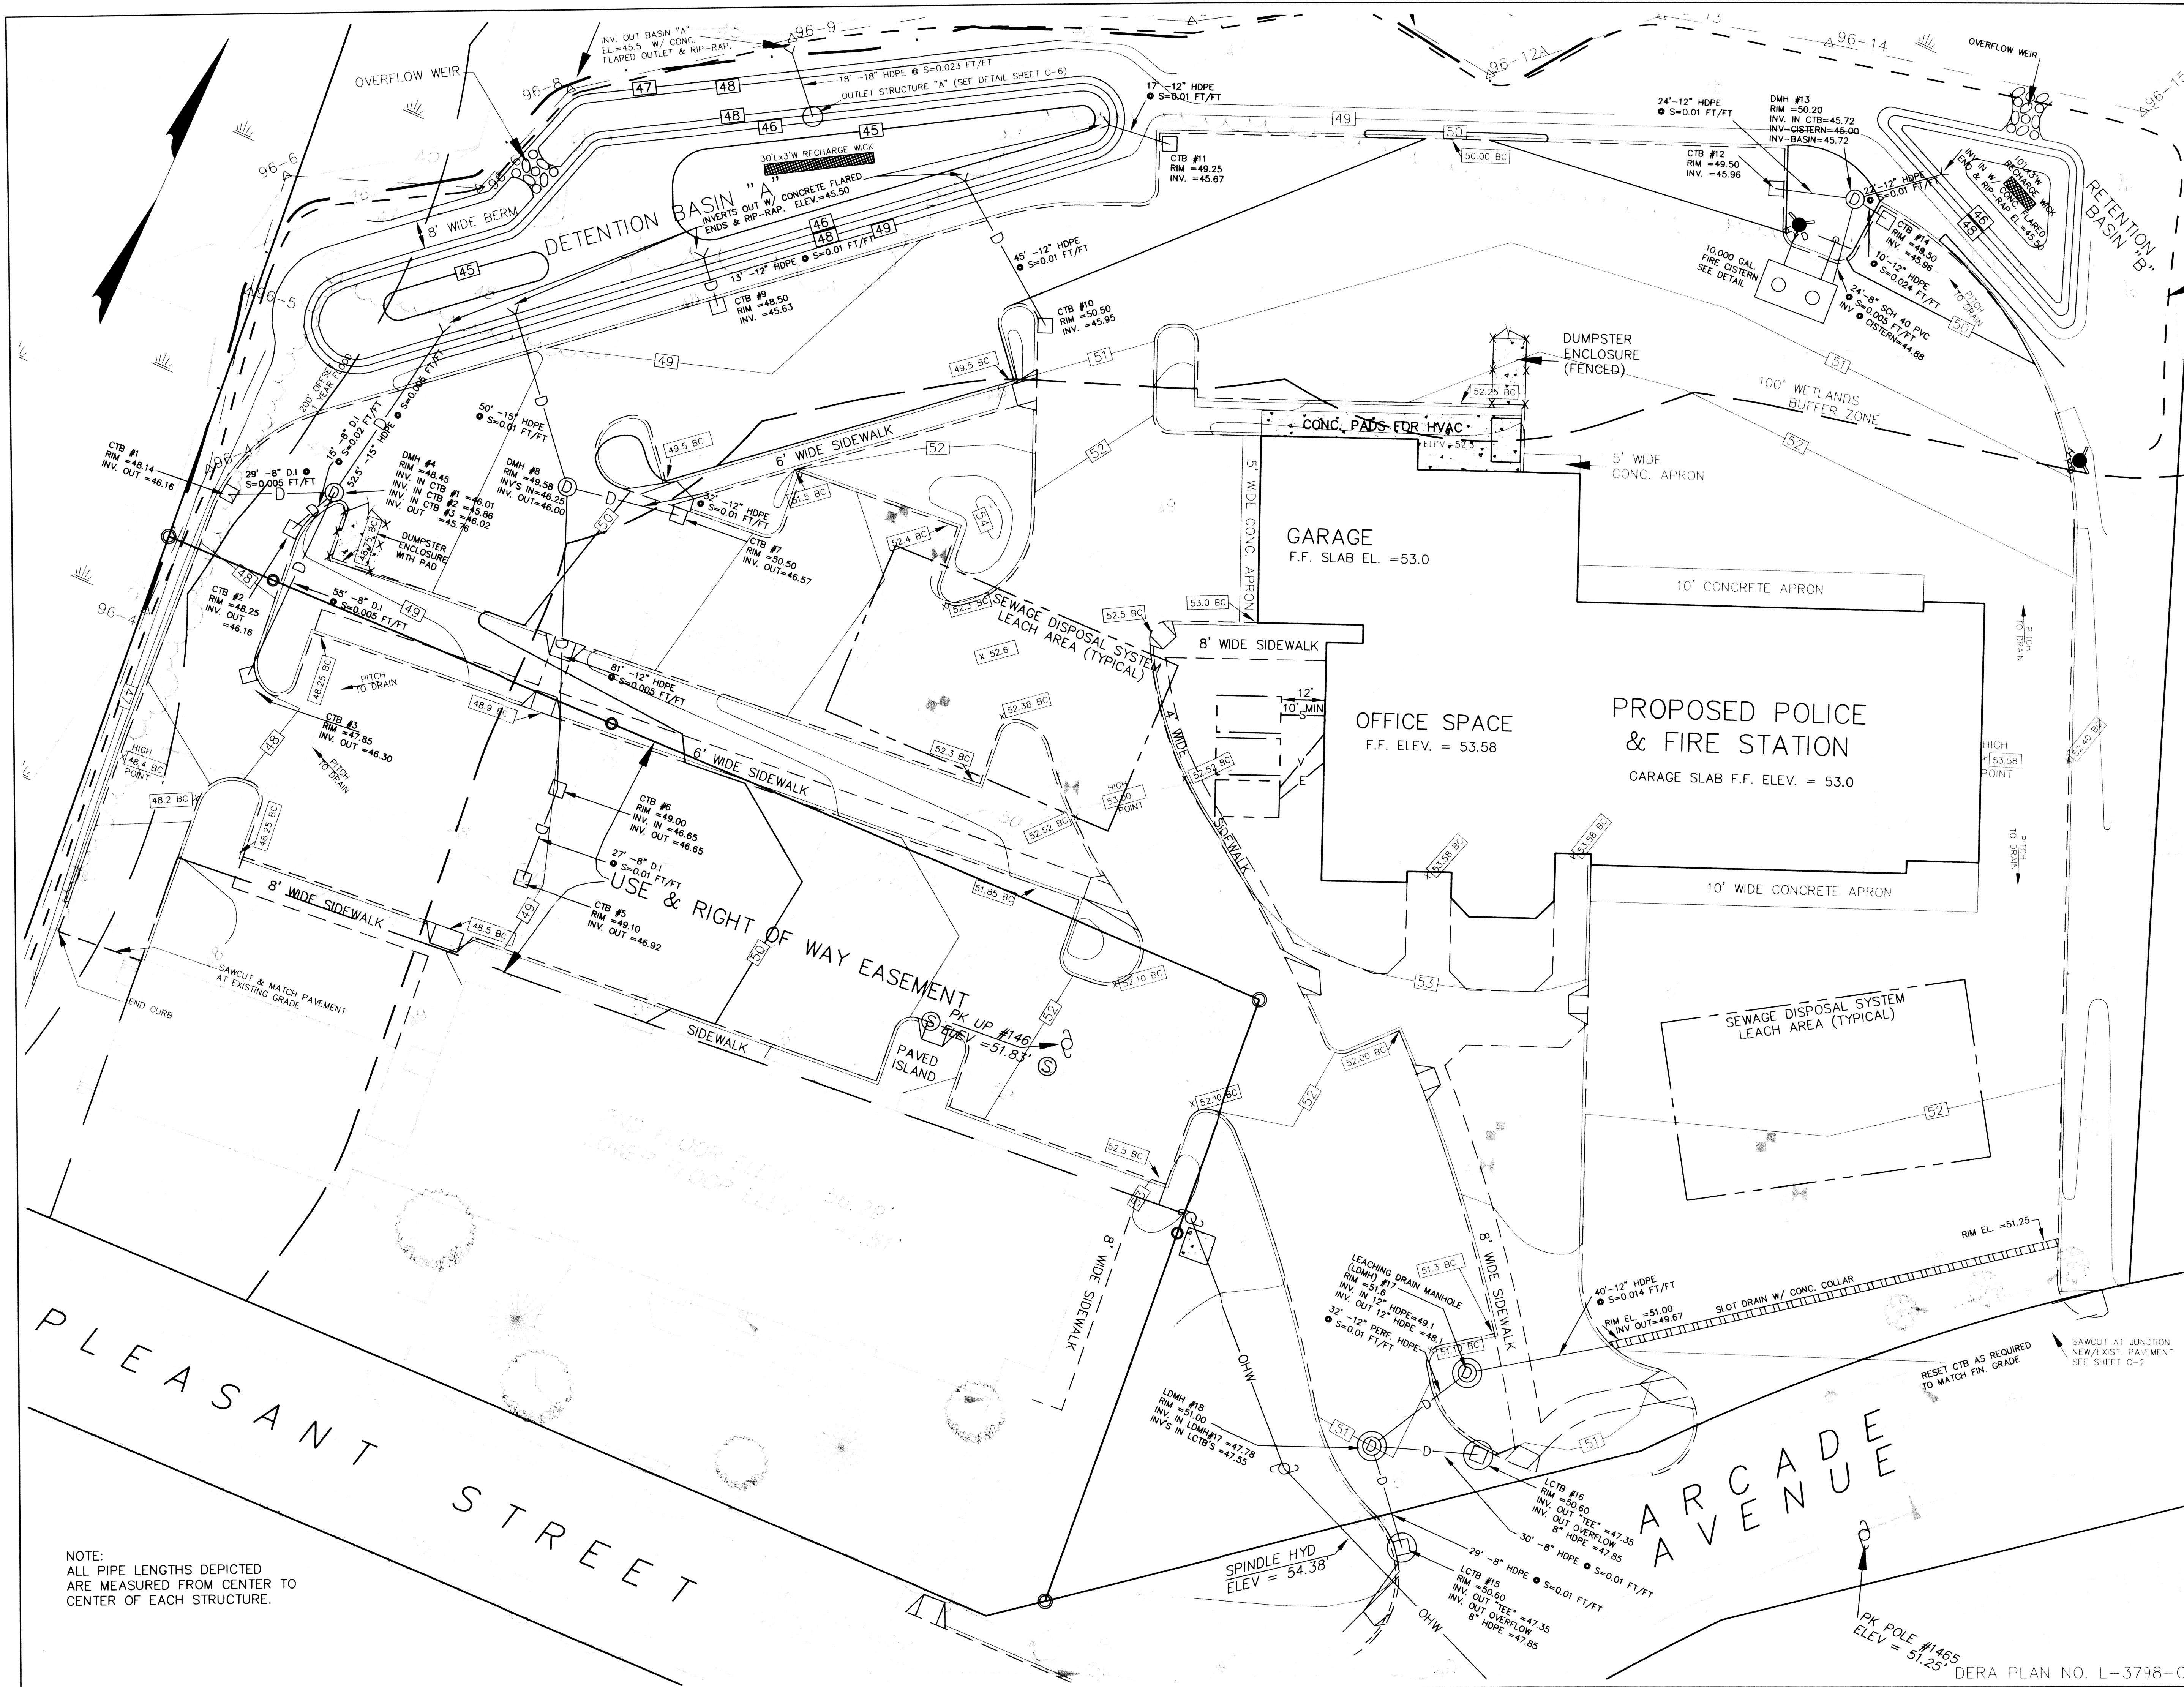

NOTE:
ALL PIPE LENGTHS DEPICTED
ARE MEASURED FROM CENTER TO
CENTER OF EACH STRUCTURE.