




SEEKONK WATER DISTRICT SEEKONK, MASSACHUSETTS CONSTRUCTION OF WATER TRANSMISSION MAINS AND APPURTENANT WORK CONTRACT NO. 2002-W1 DWSRF #842

OCTOBER 2001


SHEET No.	DISCIPLINE	DESCRIPTION
1	CIVIL	PLANS 1 - WATER LANE AND NEWMAN AVENUE
2	CIVIL	PLANS 2 - NEWMAN AND BROWN AVENUES
3	CIVIL	PLANS 3 - BROWN AVENUE AND EASEMENT
4	CIVIL	PLANS 4 - EASEMENT AND WATER DISTRICT PROPERTY
5	CIVIL	PLANS 5 - McHALE'S PUMP STATION, WATER DISTRICT PROPERTY AND EROSION CONTROL DETAILS
6	CIVIL	PLANS 6 - DETAILS AND LEGEND

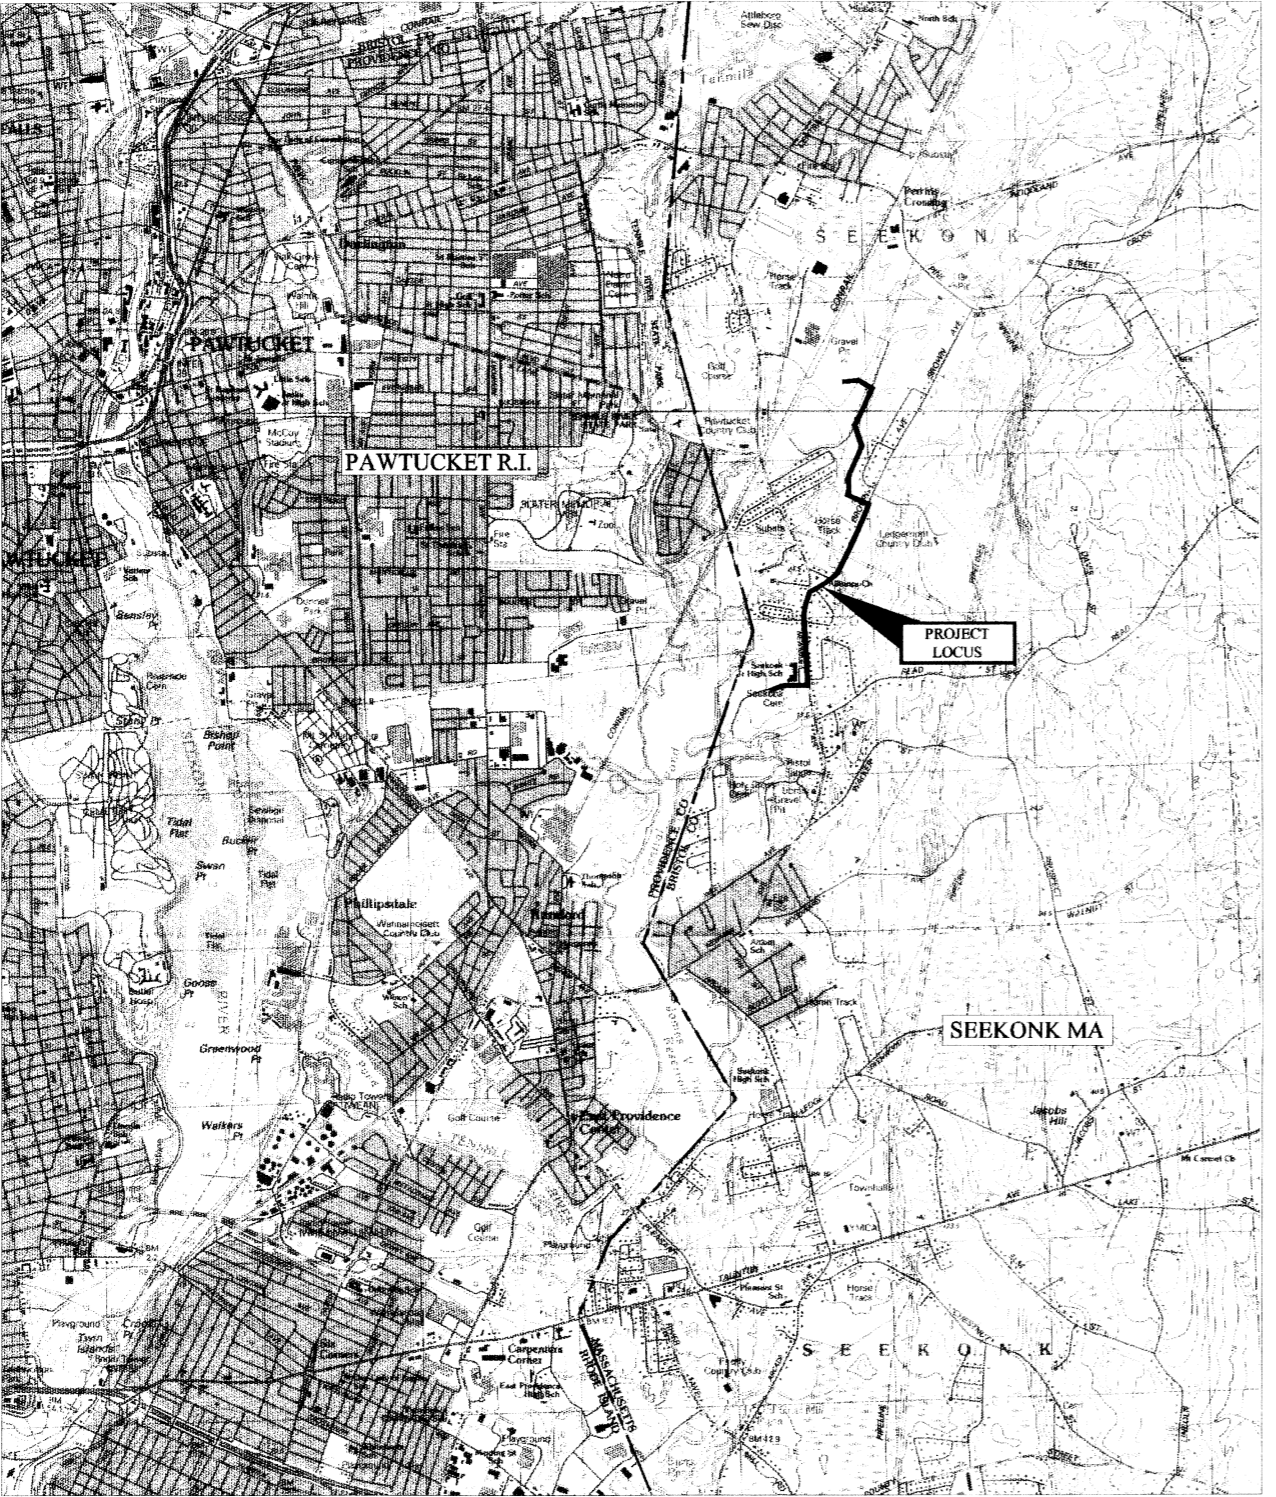

 LOCUS PLAN

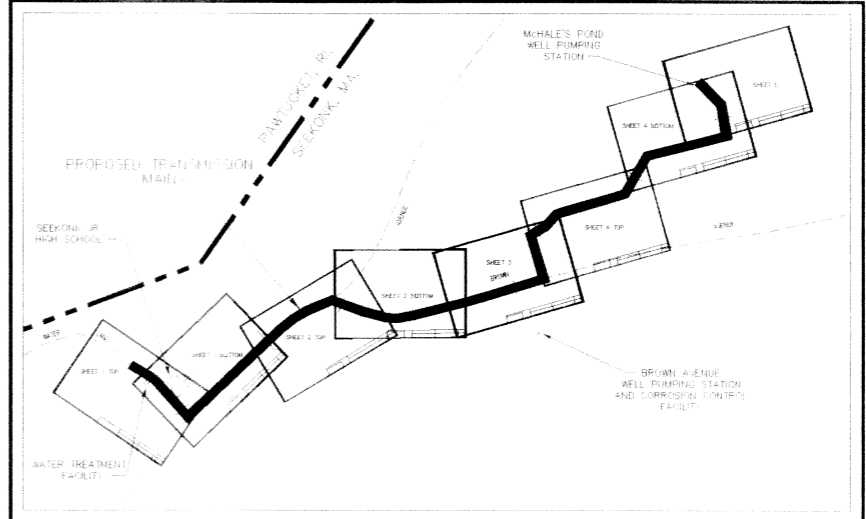

INDEX PLAN

 

NOV 05 2001

REDUCTION
NOTE: DRAWINGS REDUCED
50%

NOTES:

- REFER TO THE APPENDIX OF THE CONTRACT DOCUMENTS FOR GENERAL NOTES AND STANDARD DETAILS.
- INFORMATION ON EXISTING CONDITIONS SHOWN ON THE DRAWINGS IS APPROXIMATE ONLY.
- TOPOGRAPHY BASED ON 1929 N.G.V.D.



SEEKONK WATER DISTRICT

50 WATER LANE
P.O. BOX 97
SEEKONK, MASSACHUSETTS
02771
TELEPHONE: (508) 761-8170
FACSIMILE: (508) 761-9928

BOARD OF WATER COMMISSIONERS

ROBERT T. FULLER - CHAIRMAN
KENNETH A. LAGERQUIST - VICE CHAIRMAN
FREEMAN E. TREACY - SECRETARY

BRUCE S. BALDWIN - SUPERINTENDENT

AMORY ENGINEERS, P.C.

25 DEPOT STREET
P.O. BOX 1768
DUXBURY, MASSACHUSETTS
PHONE: 781-934-0178
FACSIMILE: 781-934-6499
<http://www.amoryengineers.com>