

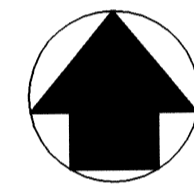




LOCATION PLAN

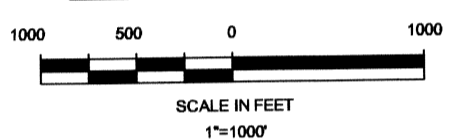


NOTE: BASE MAP TAKEN FROM MASS GIS SCANNED USGS QUADS 5-CD SET - JULY 1998 - CD 4

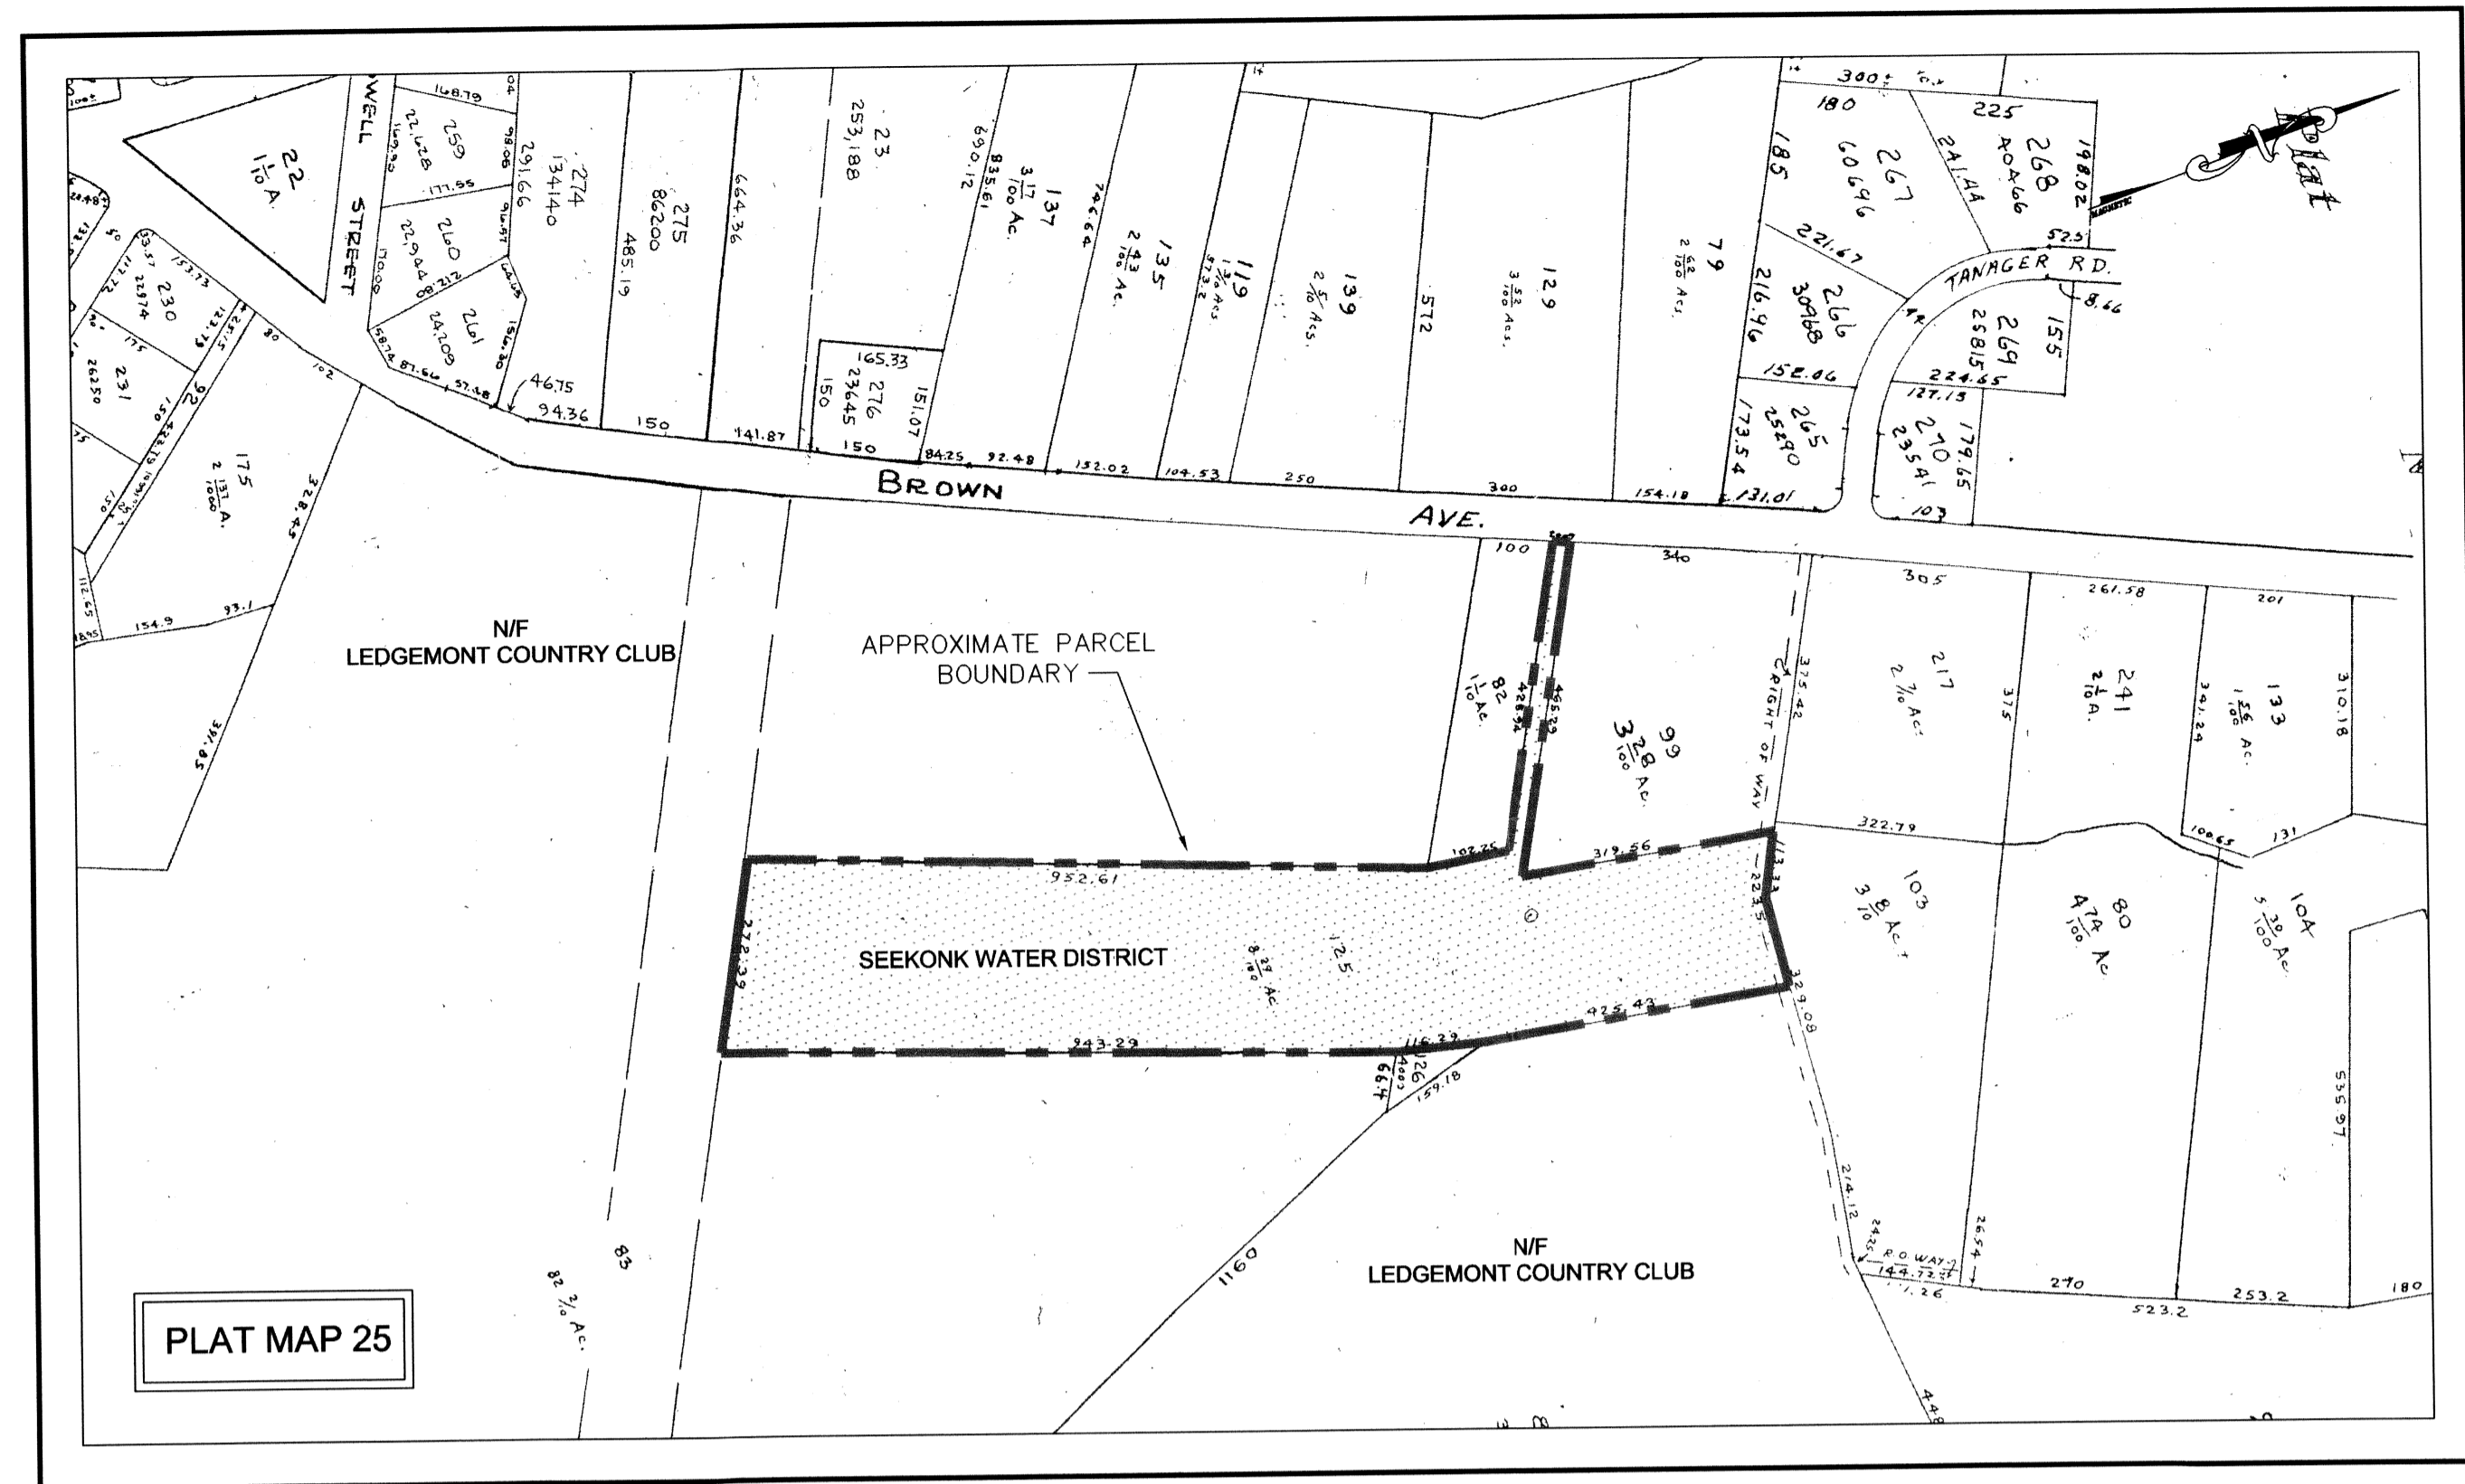

ABUTTER PLAN

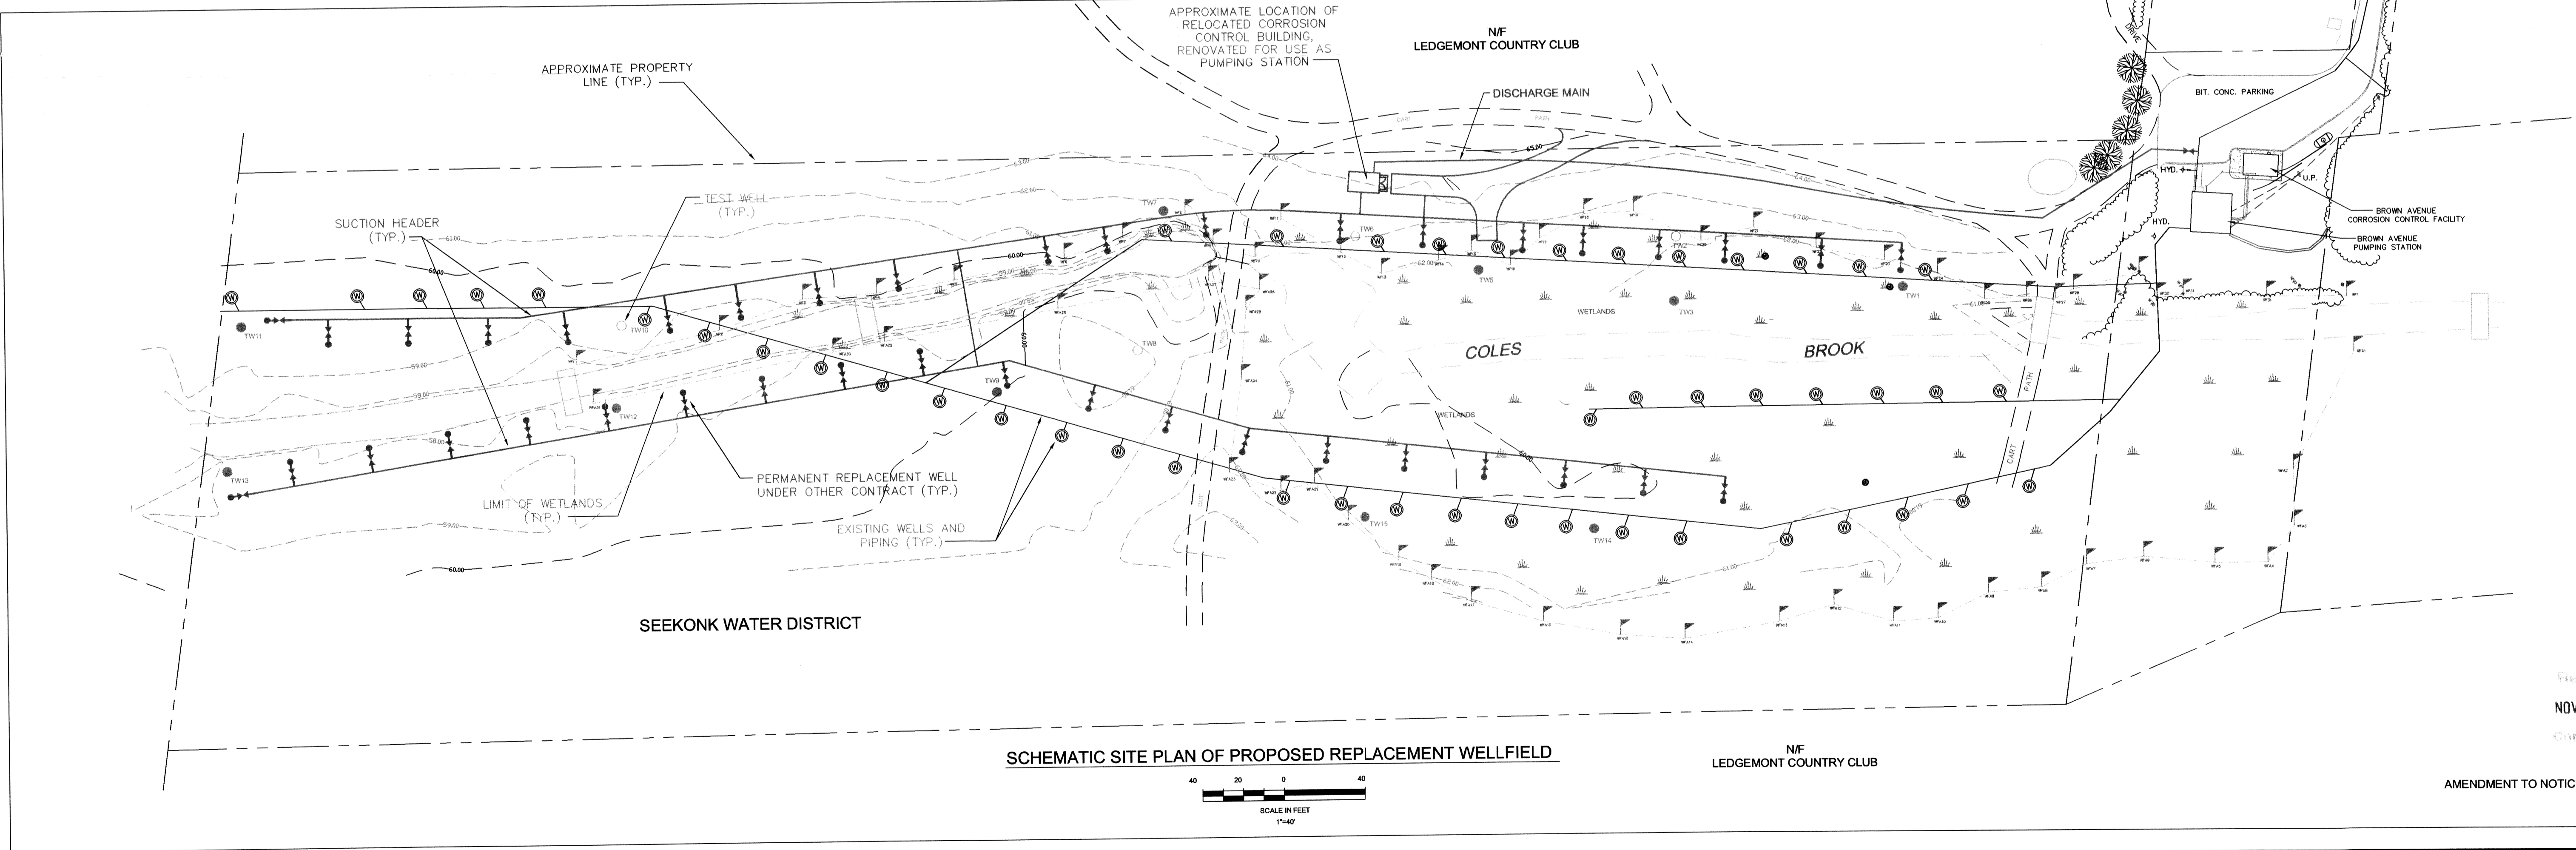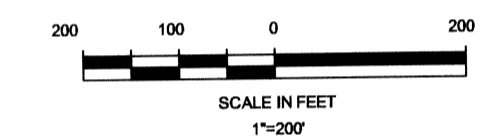

SCHEMATIC SITE PLAN OF PROPOSED REPLACEMENT WELLFIELD

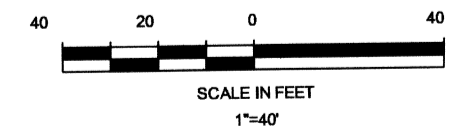

- LEGEND**
- TW1 - TEST WELL LEFT IN PLACE
  - TW2 - TEST WELL REMOVED
  - REPLACEMENT WELL AND ISOLATION VALVE
  - ⊙ EXISTING TESTWELL

**AMORY ENGINEERS, P.C.**  
DUXBURY, MASSACHUSETTS

DRAWN BY: JDF	FILE NAME: AS SHOWN	SCALE: 1" = 40'-0"
DESIGNED BY: JGS	JOB NO.: 2389	DWG. NO.: ***
CHECKED BY: DAJ	DATE: NOVEMBER 2001	CONTRACT: ***

SEEKONK WATER DISTRICT  
SEEKONK, MASSACHUSETTS

BROWN AVENUE REPLACEMENT  
WELLFIELD

FIGURE 1

SHEET

1 OF 1

Received  
NOV 19 2001  
Gen. Comm.

AMENDMENT TO NOTICE OF INTENT

P:\Clients\Seekonk\2317 Brown Preliminary\NOTICE OF INTENT WELLFIELD FIGURE1.dwg