

NOTES:

1. RAISE ALL EXISTING STRUCTURE FRAME, GRATE, COVER TO FINISH GRADE AS INDICATED ON PLANS.
2. EXISTING UTILITY INFORMATION SHOWN ON THIS PLAN IS COMPILED FROM A FIELD SURVEY AND IS APPROXIMATE ONLY. OIG SAFE AND THE RESPECTIVE UTILITY COMPANIES SHOULD BE NOTIFIED PRIOR TO COMMENCING ANY CONSTRUCTION AND/OR REVISIONS IN THE FIELD.
3. PROPOSED WATER MAIN TO BE INSTALLED ACCORDING TO THE TOWN OF SEEKONK AND TOWN ENGINEER STANDARDS. THROUST BLOCKS TO BE INSTALLED AT ALL SEAMS AND TEES.
4. GROUND WATER AT TEST PIT #6 ELEV. 14.00 WITH ONE FOOT ADD. ON, ASSUMED WITH SEASONAL SWING OF HEALTHY WELLS ON 5/17/80.
5. SEE DRAWING ESH-1 FOR UNDERGROUND ELECTRIC CONDUIT.

BENCHMARKS

BM #1: 1.00' CONC. ON TOP OF CONCRETE FOUNDATION
ELEV. = 16.33


BM #2: 1.00' CONC. ON TOP OF CONCRETE FOUNDATION
ELEV. = 16.33

BM #3: 1.00' CONC. ON TOP OF CONCRETE FOUNDATION
ELEV. = 16.33

BM #4: 1.00' CONC. ON TOP OF CONCRETE FOUNDATION
ELEV. = 16.33

LEGEND

○	CATCH BASIN
○	DRAIN MANHOLE
○	SEWER MANHOLE
○	REINFORCED CONCRETE PIPE
○	CATCH BASIN PIPE
○	GAS GATE
○	HYDRANT
○	SEWER
○	DRAIN
○	GAS
○	MASSACHUSETTS HIGHWAY ROUTE

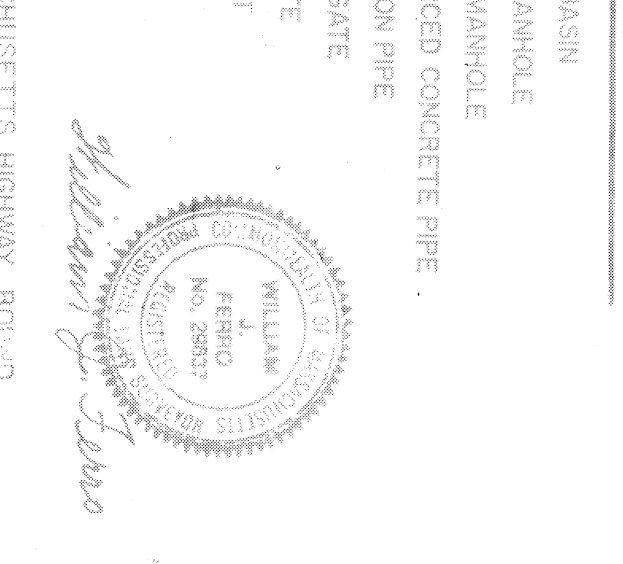

NO.	DATE	REVISIONS
1	11/2/90	CONSTRUCTION NOTES
2	11/2/90	REVISIONS
3	11/2/90	PLANNING BOARD
4	11/2/90	PERMITS
5	11/2/90	COLLECTION

SEEKONK MALL TRUST
SEEKONK, MASSACHUSETTS
GRADING AND UTILITY PLAN

DATE: NOV. 2, 1990
SCALE: 1" = 30'
DRAWN BY: S.C.
CHECKED BY:

PROJECT NO. 8917300
DRAWING NO. 3

LEA GROUP
770 North Main Street
Seekonk, MA 01534-0000
Tel: (508) 548-0000