



SITE PLAN (118 PARKING SPACES)
1" = 20'

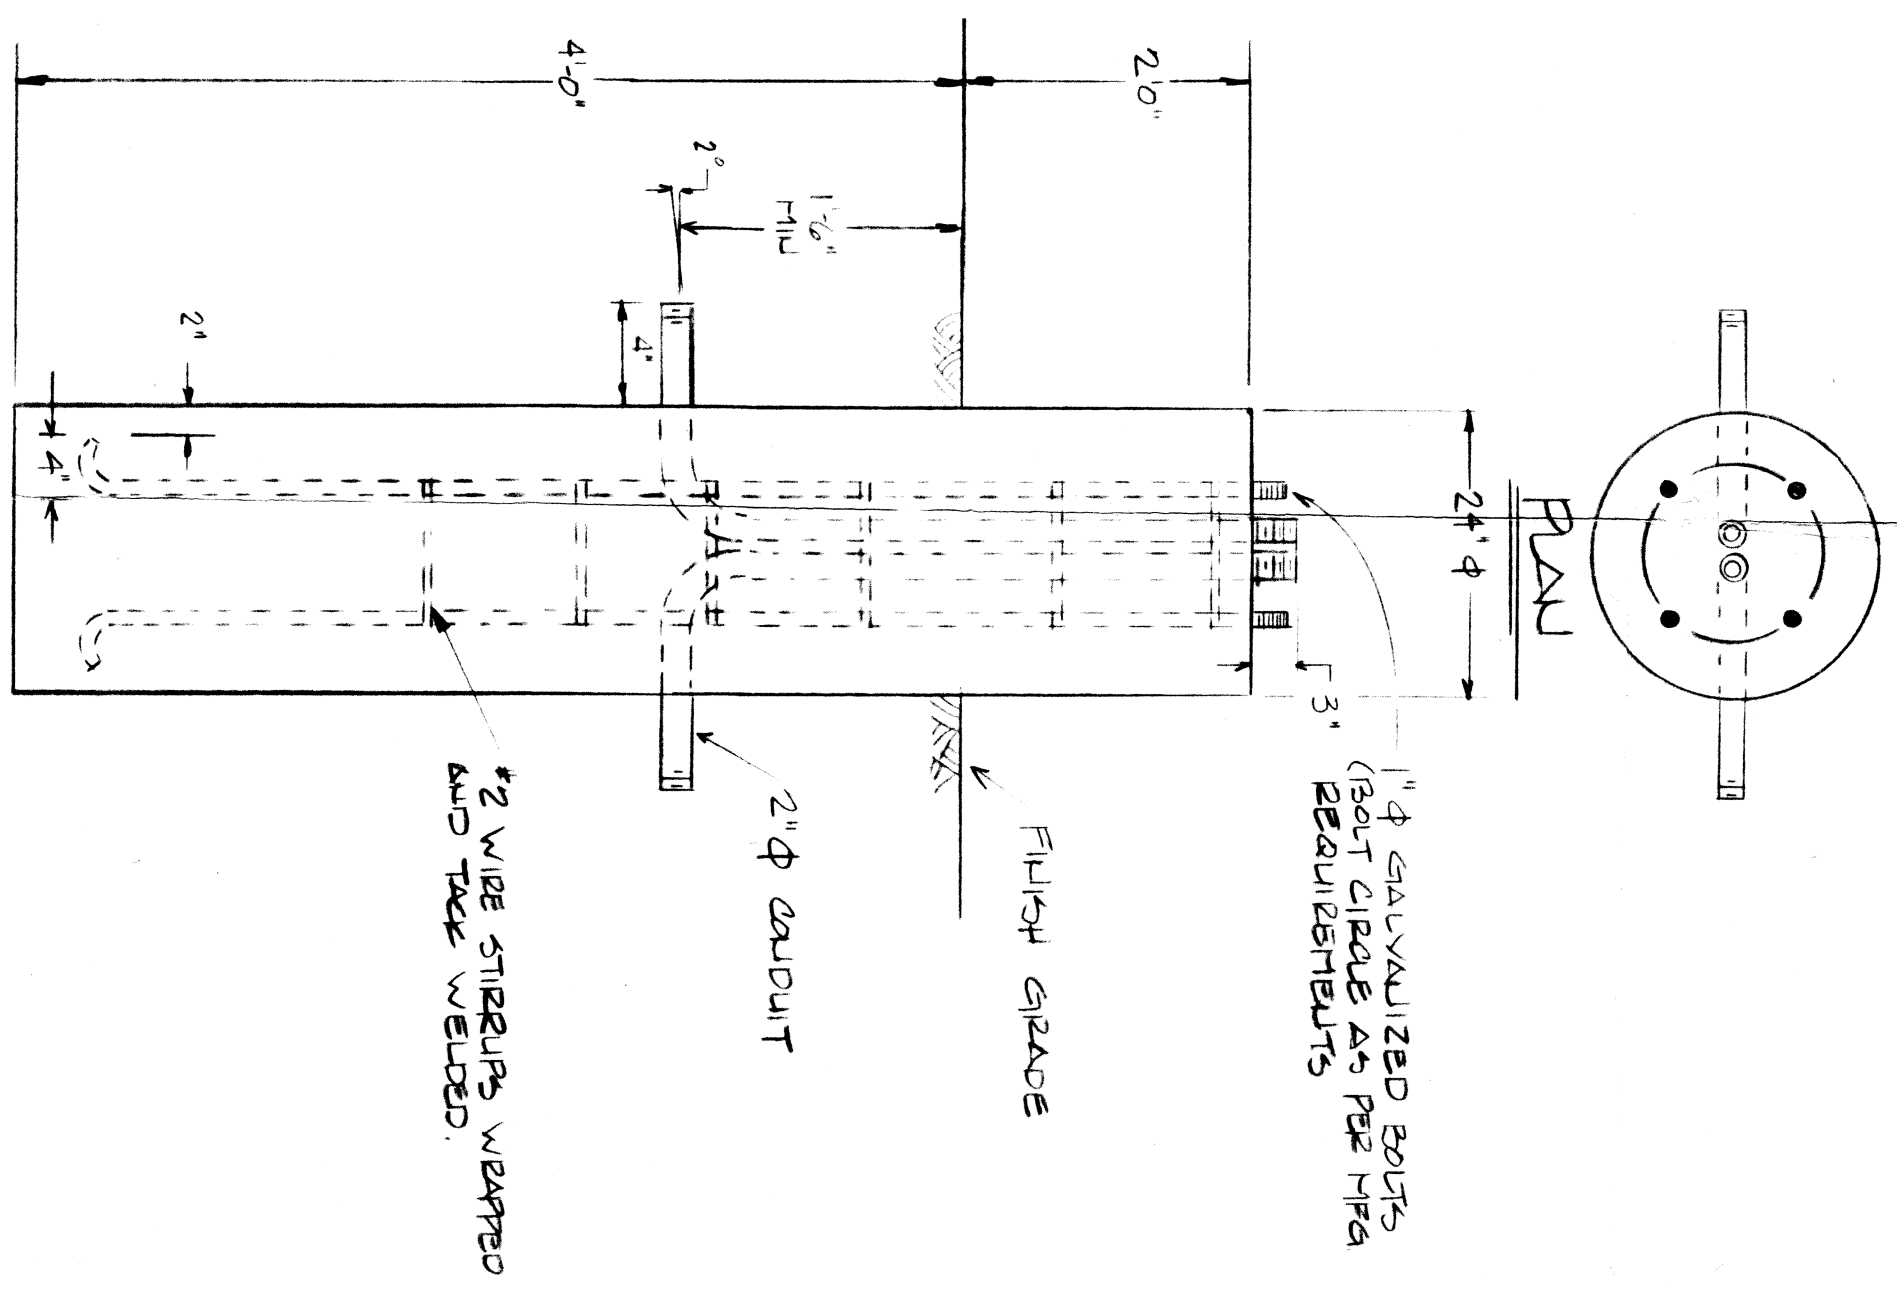

LIGHT POLE BASE (TYPICAL FOR 6)
1/16" SCALE

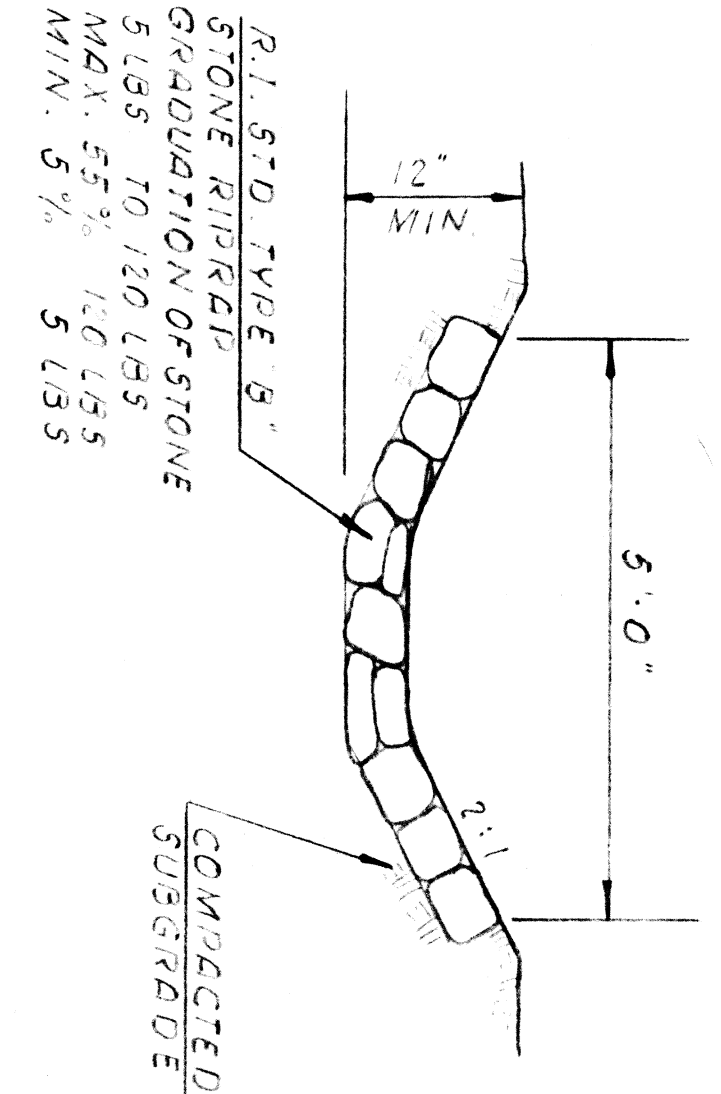

STONE RIPRAP DITCH DETAIL
NO SCALE

- GENERAL NOTES**
- FOR GENERAL NOTES AND LEGEND SEE SITE & DRAINAGE PLAN SET.
 - THE CONTRACTOR TO PROVIDE 4" GRAV & SEED A MINIMUM OF 5' BEYOND ALL DISTURBED AREAS.

- ELECTRICAL NOTES**
- PROVIDE AND INSTALL NEW HARDWARE AS FOLLOWS:
 - NEW DISTRIBUTION RIG TO MATCH EXISTING.
 - NEW 1/2\"/>
 - NEW ELECTRICAL HANDHOLES WITH PANELS & COVERS. F.I. STD. 18.10.
 - NEW LIGHT POLE & BASE.

- ELECTRICAL LEGEND**
- E- NEW ELECTRICAL FEED
 - NEW ELECTRICAL HANDHOLES WITH PANELS & COVERS. F.I. STD. 18.10.
 - NEW LIGHT POLE & BASE

KRATZ
Professional Engineers
366 State Street
Taunton, MA 01960
Tel: 508-848-1111

JOHNSON & WALES INN
ROUTE 44
TAUNTON AVE.
SEEKONK
MASS.

Scale: 2.5" = 1'-0"
Designed By: DSP
Checked By: AD
Date: 08/28/01

SITE PARKING & DRAINAGE PLAN
SITE ENGINEERING SE-2

KEYES
801-29-00